

ELECTRICAL LEGEND


Table with 2 columns: Symbol and Description. Symbols include light fixture, receptacle, switch, and various electrical components. Descriptions include 'LIGHT FIXTURE DESIGNATION', 'RECEPTACLE', 'SWITCH', 'MOTOR STARTER', etc.

ELECTRICAL GENERAL NOTES

- 1. ALL WORK UNDERGROUND SHALL BE PERMITTED TO BE DONE BY A LICENSED ELECTRICAL CONTRACTOR IN A FIRST CLASS PERFORMANCE GRADE UNDER E-3 AND COMPLIANCE WITH ALL REQUIREMENTS SET FORTH BY ANY LOCAL ORDINANCE AND GOVERNING AUTHORITIES.
2. CONNECTION SHALL BE IN ACCORDANCE WITH THE NATIONAL ELECTRICAL CODE (NEC) AND THE NATIONAL FIRE ALARMS CODE (NFPA) LOCAL CODES, RULES 2014, AND ORDINANCES HAVING JURISDICTION FOR 2014.
3. IT SHALL BE THE RESPONSIBILITY OF THE ELECTRICAL CONTRACTOR TO WORK WITH ALL AGENCIES, AGENCIES AND AGENCIES TO ACCOMPLISH THE WORK.
4. ALL REQUIRED PERMITS SHALL BE OBTAINED FOR PROTECTION AGAINST PUBLIC UTILITY AND PROPERTY DAMAGE FOR THE LOCATION OF THE WORK.
5. ELECTRICAL CONTRACTOR SHALL VERIFY THE JOB SITE PRIOR TO GOING AND VERIFY ALL CONDITIONS, LOCATIONS, DIMENSIONS AND CONDITIONS AS SHOWN AND NOTED ON THE INSTALLATION. IT SHALL BE THE RESPONSIBILITY OF THE ELECTRICAL CONTRACTOR FOR THE PRODUCTION OF OTHER TRADES TO BE DONE IN ANY ROOM OR ON THE TIME.
6. CONTRACTOR SHALL GUARANTEE ALL MATERIALS AND WORKMANSHIP FREE FROM DEFECTS AND DEFICIENCIES FOR A PERIOD OF ONE YEAR FROM DATE OF ACCEPTANCE.
7. CORRECTION OF ANY DEFECTS SHALL BE COMPLETED WITHOUT ADDITIONAL CHARGE AND SHALL INCLUDE REPAIRS OR REPLACE OF ANY OTHER PARTS OF THE INSTALLATION.
8. THE ELECTRICAL CONTRACTOR SHALL BE RESPONSIBLE FOR PROTECTING ALL EXISTING UTILITIES AND STRUCTURES.
9. ALL ELECTRICAL EQUIPMENT SHALL BE INSTALLED IN ACCORDANCE WITH THE NATIONAL ELECTRICAL CODE (NEC) AND THE NATIONAL FIRE ALARMS CODE (NFPA) LOCAL CODES, RULES 2014, AND ORDINANCES HAVING JURISDICTION FOR 2014.
10. ALL ELECTRICAL EQUIPMENT SHALL BE INSTALLED IN ACCORDANCE WITH THE NATIONAL ELECTRICAL CODE (NEC) AND THE NATIONAL FIRE ALARMS CODE (NFPA) LOCAL CODES, RULES 2014, AND ORDINANCES HAVING JURISDICTION FOR 2014.
11. ALL ELECTRICAL EQUIPMENT SHALL BE INSTALLED IN ACCORDANCE WITH THE NATIONAL ELECTRICAL CODE (NEC) AND THE NATIONAL FIRE ALARMS CODE (NFPA) LOCAL CODES, RULES 2014, AND ORDINANCES HAVING JURISDICTION FOR 2014.
12. ALL ELECTRICAL EQUIPMENT SHALL BE INSTALLED IN ACCORDANCE WITH THE NATIONAL ELECTRICAL CODE (NEC) AND THE NATIONAL FIRE ALARMS CODE (NFPA) LOCAL CODES, RULES 2014, AND ORDINANCES HAVING JURISDICTION FOR 2014.
13. ALL ELECTRICAL EQUIPMENT SHALL BE INSTALLED IN ACCORDANCE WITH THE NATIONAL ELECTRICAL CODE (NEC) AND THE NATIONAL FIRE ALARMS CODE (NFPA) LOCAL CODES, RULES 2014, AND ORDINANCES HAVING JURISDICTION FOR 2014.
14. ALL ELECTRICAL EQUIPMENT SHALL BE INSTALLED IN ACCORDANCE WITH THE NATIONAL ELECTRICAL CODE (NEC) AND THE NATIONAL FIRE ALARMS CODE (NFPA) LOCAL CODES, RULES 2014, AND ORDINANCES HAVING JURISDICTION FOR 2014.
15. ALL ELECTRICAL EQUIPMENT SHALL BE INSTALLED IN ACCORDANCE WITH THE NATIONAL ELECTRICAL CODE (NEC) AND THE NATIONAL FIRE ALARMS CODE (NFPA) LOCAL CODES, RULES 2014, AND ORDINANCES HAVING JURISDICTION FOR 2014.
16. ALL ELECTRICAL EQUIPMENT SHALL BE INSTALLED IN ACCORDANCE WITH THE NATIONAL ELECTRICAL CODE (NEC) AND THE NATIONAL FIRE ALARMS CODE (NFPA) LOCAL CODES, RULES 2014, AND ORDINANCES HAVING JURISDICTION FOR 2014.
17. ALL ELECTRICAL EQUIPMENT SHALL BE INSTALLED IN ACCORDANCE WITH THE NATIONAL ELECTRICAL CODE (NEC) AND THE NATIONAL FIRE ALARMS CODE (NFPA) LOCAL CODES, RULES 2014, AND ORDINANCES HAVING JURISDICTION FOR 2014.
18. ALL ELECTRICAL EQUIPMENT SHALL BE INSTALLED IN ACCORDANCE WITH THE NATIONAL ELECTRICAL CODE (NEC) AND THE NATIONAL FIRE ALARMS CODE (NFPA) LOCAL CODES, RULES 2014, AND ORDINANCES HAVING JURISDICTION FOR 2014.
19. ALL ELECTRICAL EQUIPMENT SHALL BE INSTALLED IN ACCORDANCE WITH THE NATIONAL ELECTRICAL CODE (NEC) AND THE NATIONAL FIRE ALARMS CODE (NFPA) LOCAL CODES, RULES 2014, AND ORDINANCES HAVING JURISDICTION FOR 2014.
20. ALL ELECTRICAL EQUIPMENT SHALL BE INSTALLED IN ACCORDANCE WITH THE NATIONAL ELECTRICAL CODE (NEC) AND THE NATIONAL FIRE ALARMS CODE (NFPA) LOCAL CODES, RULES 2014, AND ORDINANCES HAVING JURISDICTION FOR 2014.
21. ALL ELECTRICAL EQUIPMENT SHALL BE INSTALLED IN ACCORDANCE WITH THE NATIONAL ELECTRICAL CODE (NEC) AND THE NATIONAL FIRE ALARMS CODE (NFPA) LOCAL CODES, RULES 2014, AND ORDINANCES HAVING JURISDICTION FOR 2014.
22. ALL ELECTRICAL EQUIPMENT SHALL BE INSTALLED IN ACCORDANCE WITH THE NATIONAL ELECTRICAL CODE (NEC) AND THE NATIONAL FIRE ALARMS CODE (NFPA) LOCAL CODES, RULES 2014, AND ORDINANCES HAVING JURISDICTION FOR 2014.
23. ALL ELECTRICAL EQUIPMENT SHALL BE INSTALLED IN ACCORDANCE WITH THE NATIONAL ELECTRICAL CODE (NEC) AND THE NATIONAL FIRE ALARMS CODE (NFPA) LOCAL CODES, RULES 2014, AND ORDINANCES HAVING JURISDICTION FOR 2014.
24. ALL ELECTRICAL EQUIPMENT SHALL BE INSTALLED IN ACCORDANCE WITH THE NATIONAL ELECTRICAL CODE (NEC) AND THE NATIONAL FIRE ALARMS CODE (NFPA) LOCAL CODES, RULES 2014, AND ORDINANCES HAVING JURISDICTION FOR 2014.
25. ALL ELECTRICAL EQUIPMENT SHALL BE INSTALLED IN ACCORDANCE WITH THE NATIONAL ELECTRICAL CODE (NEC) AND THE NATIONAL FIRE ALARMS CODE (NFPA) LOCAL CODES, RULES 2014, AND ORDINANCES HAVING JURISDICTION FOR 2014.
26. ALL ELECTRICAL EQUIPMENT SHALL BE INSTALLED IN ACCORDANCE WITH THE NATIONAL ELECTRICAL CODE (NEC) AND THE NATIONAL FIRE ALARMS CODE (NFPA) LOCAL CODES, RULES 2014, AND ORDINANCES HAVING JURISDICTION FOR 2014.
27. ALL ELECTRICAL EQUIPMENT SHALL BE INSTALLED IN ACCORDANCE WITH THE NATIONAL ELECTRICAL CODE (NEC) AND THE NATIONAL FIRE ALARMS CODE (NFPA) LOCAL CODES, RULES 2014, AND ORDINANCES HAVING JURISDICTION FOR 2014.
28. ALL ELECTRICAL EQUIPMENT SHALL BE INSTALLED IN ACCORDANCE WITH THE NATIONAL ELECTRICAL CODE (NEC) AND THE NATIONAL FIRE ALARMS CODE (NFPA) LOCAL CODES, RULES 2014, AND ORDINANCES HAVING JURISDICTION FOR 2014.
29. ALL ELECTRICAL EQUIPMENT SHALL BE INSTALLED IN ACCORDANCE WITH THE NATIONAL ELECTRICAL CODE (NEC) AND THE NATIONAL FIRE ALARMS CODE (NFPA) LOCAL CODES, RULES 2014, AND ORDINANCES HAVING JURISDICTION FOR 2014.
30. ALL ELECTRICAL EQUIPMENT SHALL BE INSTALLED IN ACCORDANCE WITH THE NATIONAL ELECTRICAL CODE (NEC) AND THE NATIONAL FIRE ALARMS CODE (NFPA) LOCAL CODES, RULES 2014, AND ORDINANCES HAVING JURISDICTION FOR 2014.
31. ALL ELECTRICAL EQUIPMENT SHALL BE INSTALLED IN ACCORDANCE WITH THE NATIONAL ELECTRICAL CODE (NEC) AND THE NATIONAL FIRE ALARMS CODE (NFPA) LOCAL CODES, RULES 2014, AND ORDINANCES HAVING JURISDICTION FOR 2014.
32. ALL ELECTRICAL EQUIPMENT SHALL BE INSTALLED IN ACCORDANCE WITH THE NATIONAL ELECTRICAL CODE (NEC) AND THE NATIONAL FIRE ALARMS CODE (NFPA) LOCAL CODES, RULES 2014, AND ORDINANCES HAVING JURISDICTION FOR 2014.
33. ALL ELECTRICAL EQUIPMENT SHALL BE INSTALLED IN ACCORDANCE WITH THE NATIONAL ELECTRICAL CODE (NEC) AND THE NATIONAL FIRE ALARMS CODE (NFPA) LOCAL CODES, RULES 2014, AND ORDINANCES HAVING JURISDICTION FOR 2014.
34. ALL ELECTRICAL EQUIPMENT SHALL BE INSTALLED IN ACCORDANCE WITH THE NATIONAL ELECTRICAL CODE (NEC) AND THE NATIONAL FIRE ALARMS CODE (NFPA) LOCAL CODES, RULES 2014, AND ORDINANCES HAVING JURISDICTION FOR 2014.
35. ALL ELECTRICAL EQUIPMENT SHALL BE INSTALLED IN ACCORDANCE WITH THE NATIONAL ELECTRICAL CODE (NEC) AND THE NATIONAL FIRE ALARMS CODE (NFPA) LOCAL CODES, RULES 2014, AND ORDINANCES HAVING JURISDICTION FOR 2014.
36. ALL ELECTRICAL EQUIPMENT SHALL BE INSTALLED IN ACCORDANCE WITH THE NATIONAL ELECTRICAL CODE (NEC) AND THE NATIONAL FIRE ALARMS CODE (NFPA) LOCAL CODES, RULES 2014, AND ORDINANCES HAVING JURISDICTION FOR 2014.
37. ALL ELECTRICAL EQUIPMENT SHALL BE INSTALLED IN ACCORDANCE WITH THE NATIONAL ELECTRICAL CODE (NEC) AND THE NATIONAL FIRE ALARMS CODE (NFPA) LOCAL CODES, RULES 2014, AND ORDINANCES HAVING JURISDICTION FOR 2014.
38. ALL ELECTRICAL EQUIPMENT SHALL BE INSTALLED IN ACCORDANCE WITH THE NATIONAL ELECTRICAL CODE (NEC) AND THE NATIONAL FIRE ALARMS CODE (NFPA) LOCAL CODES, RULES 2014, AND ORDINANCES HAVING JURISDICTION FOR 2014.
39. ALL ELECTRICAL EQUIPMENT SHALL BE INSTALLED IN ACCORDANCE WITH THE NATIONAL ELECTRICAL CODE (NEC) AND THE NATIONAL FIRE ALARMS CODE (NFPA) LOCAL CODES, RULES 2014, AND ORDINANCES HAVING JURISDICTION FOR 2014.
40. ALL ELECTRICAL EQUIPMENT SHALL BE INSTALLED IN ACCORDANCE WITH THE NATIONAL ELECTRICAL CODE (NEC) AND THE NATIONAL FIRE ALARMS CODE (NFPA) LOCAL CODES, RULES 2014, AND ORDINANCES HAVING JURISDICTION FOR 2014.
41. ALL ELECTRICAL EQUIPMENT SHALL BE INSTALLED IN ACCORDANCE WITH THE NATIONAL ELECTRICAL CODE (NEC) AND THE NATIONAL FIRE ALARMS CODE (NFPA) LOCAL CODES, RULES 2014, AND ORDINANCES HAVING JURISDICTION FOR 2014.
42. ALL ELECTRICAL EQUIPMENT SHALL BE INSTALLED IN ACCORDANCE WITH THE NATIONAL ELECTRICAL CODE (NEC) AND THE NATIONAL FIRE ALARMS CODE (NFPA) LOCAL CODES, RULES 2014, AND ORDINANCES HAVING JURISDICTION FOR 2014.
43. ALL ELECTRICAL EQUIPMENT SHALL BE INSTALLED IN ACCORDANCE WITH THE NATIONAL ELECTRICAL CODE (NEC) AND THE NATIONAL FIRE ALARMS CODE (NFPA) LOCAL CODES, RULES 2014, AND ORDINANCES HAVING JURISDICTION FOR 2014.
44. ALL ELECTRICAL EQUIPMENT SHALL BE INSTALLED IN ACCORDANCE WITH THE NATIONAL ELECTRICAL CODE (NEC) AND THE NATIONAL FIRE ALARMS CODE (NFPA) LOCAL CODES, RULES 2014, AND ORDINANCES HAVING JURISDICTION FOR 2014.
45. ALL ELECTRICAL EQUIPMENT SHALL BE INSTALLED IN ACCORDANCE WITH THE NATIONAL ELECTRICAL CODE (NEC) AND THE NATIONAL FIRE ALARMS CODE (NFPA) LOCAL CODES, RULES 2014, AND ORDINANCES HAVING JURISDICTION FOR 2014.
46. ALL ELECTRICAL EQUIPMENT SHALL BE INSTALLED IN ACCORDANCE WITH THE NATIONAL ELECTRICAL CODE (NEC) AND THE NATIONAL FIRE ALARMS CODE (NFPA) LOCAL CODES, RULES 2014, AND ORDINANCES HAVING JURISDICTION FOR 2014.

1 ELECTRICAL SECOND FLOOR PLAN

E-3 SCALE: N.T.S.

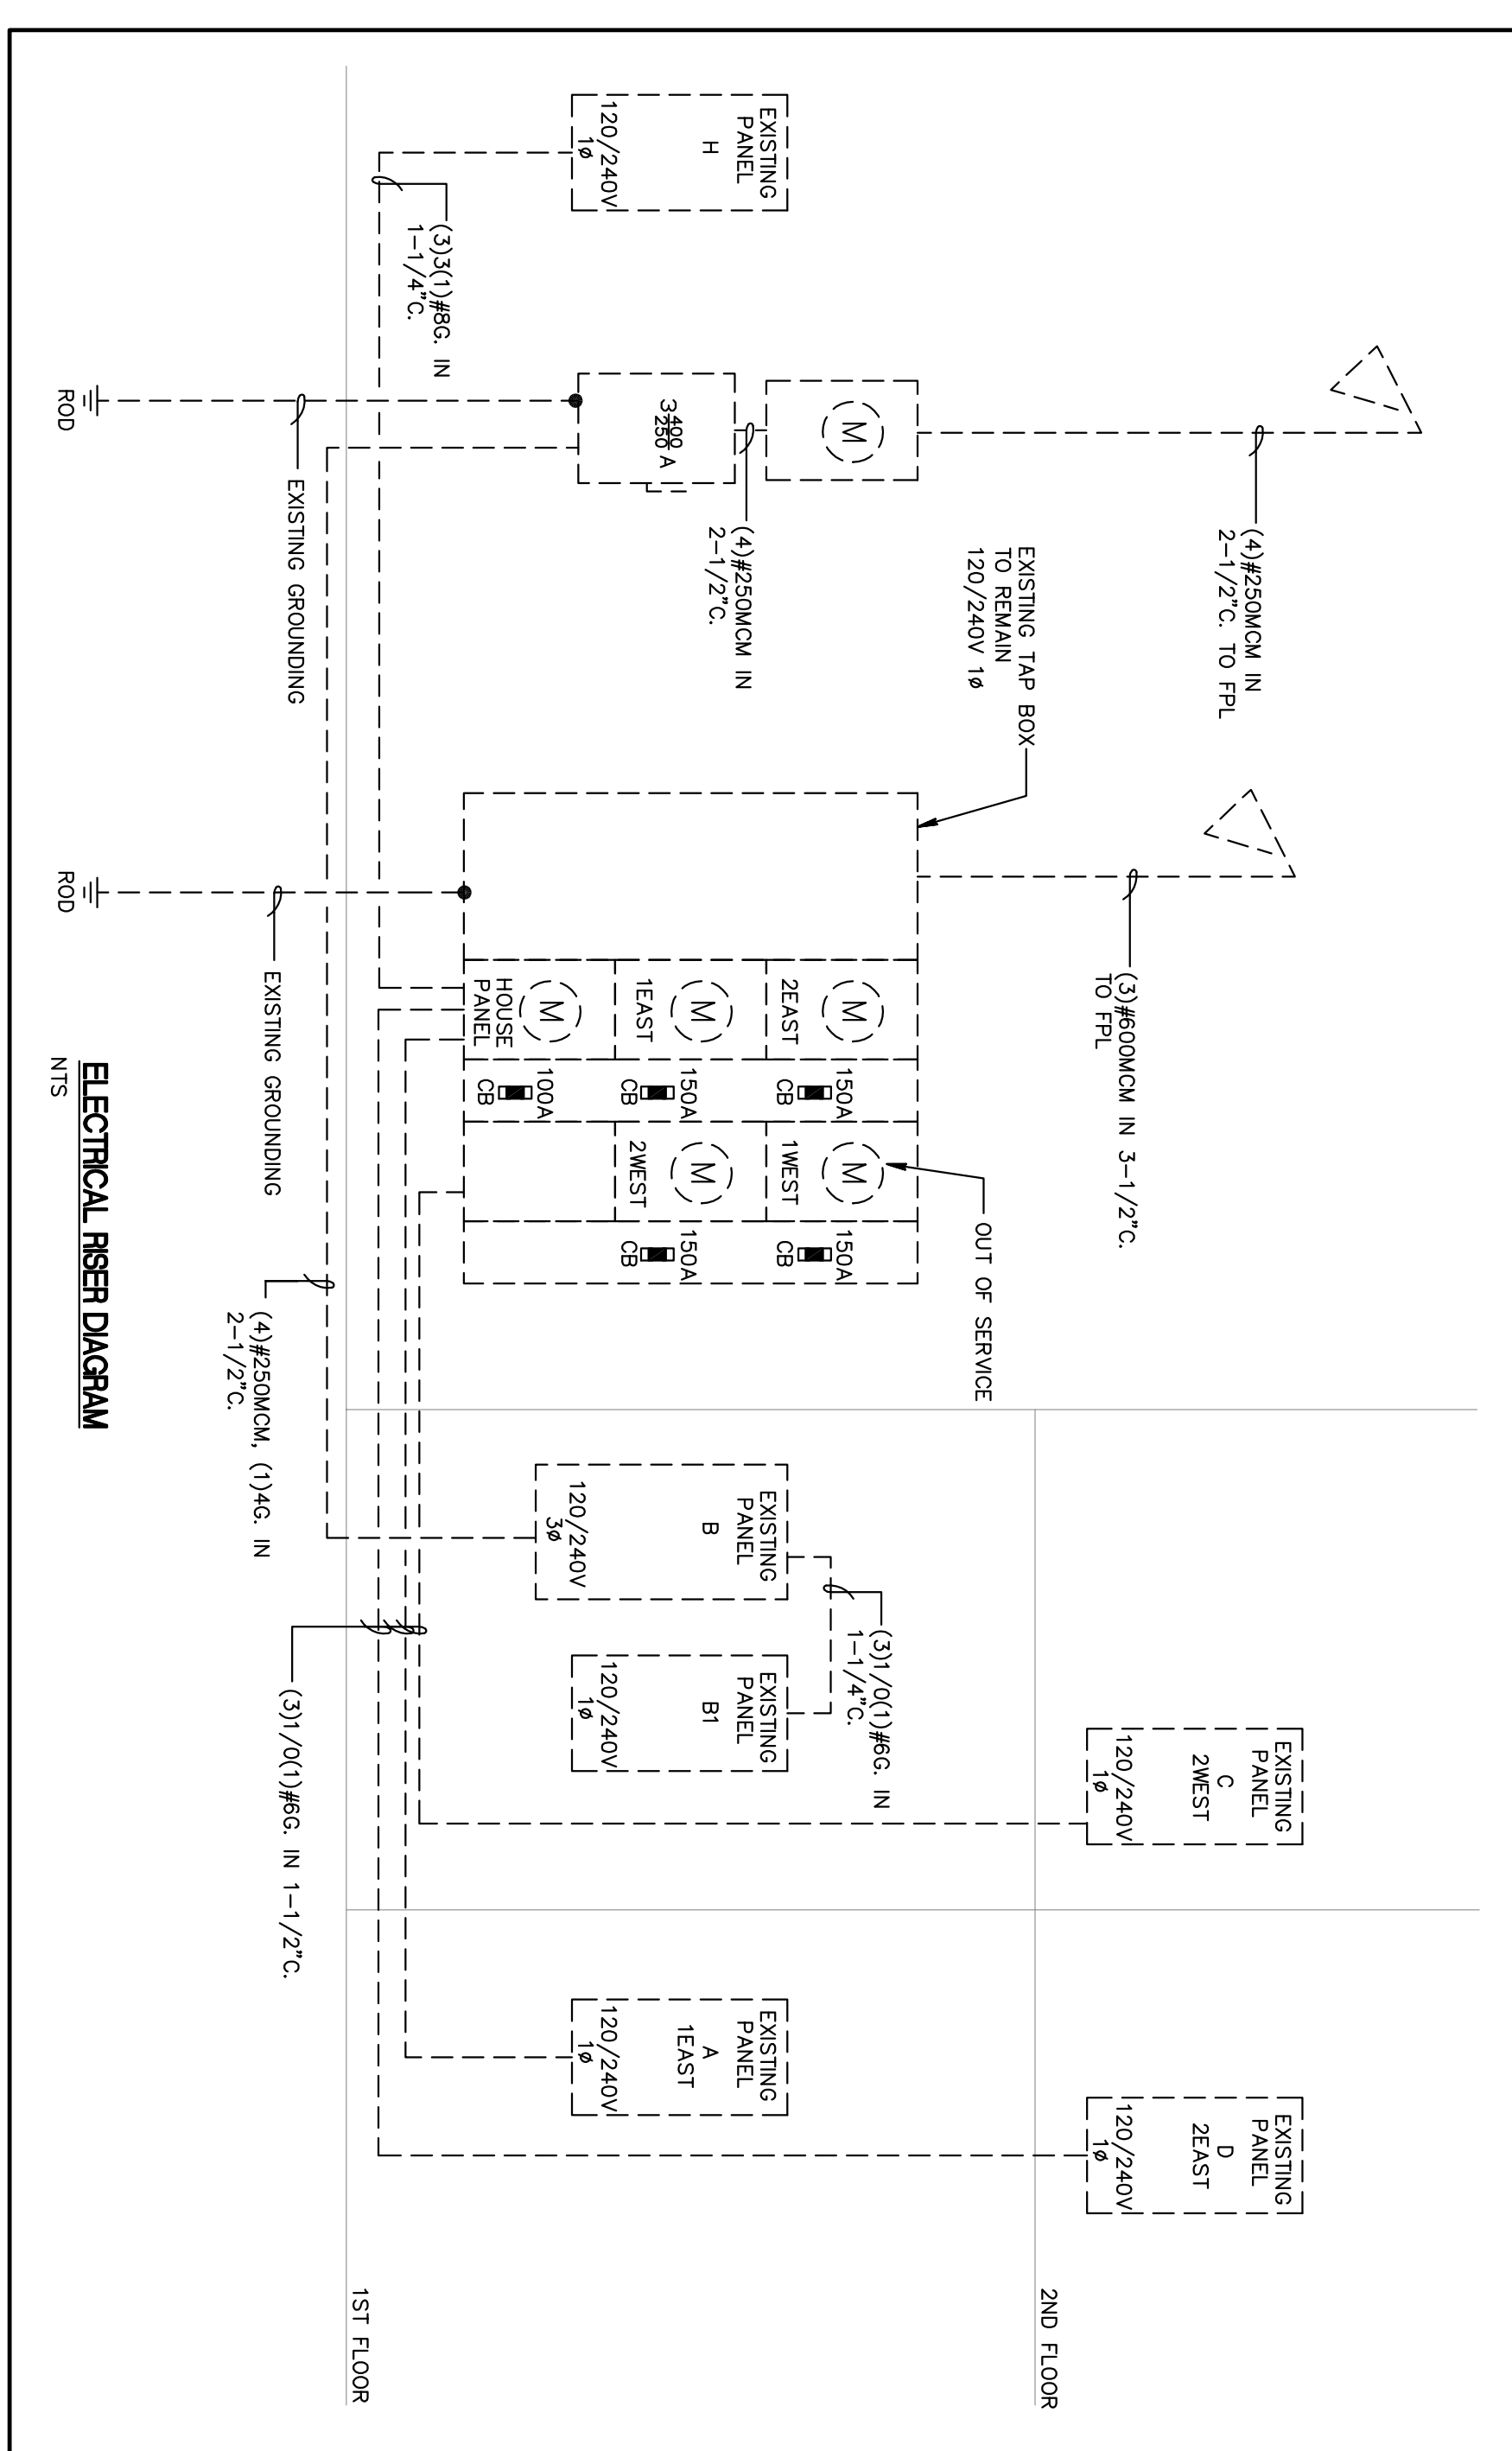

CLIENT: 701 4th Street, Interior Renovations, Miami Beach, FL 33139, Folio: 02-4203-009-3040

DDS 333 SE 2ND AVENUE, SUITE 2066 MIAMI, FL 33131 Tel: 786.218.5335 License #A.A.26002467 www.castellanosdesign.com

Table with 2 columns: No., DATE. Issued/Revised.

DESIGNER: ANABEL RODRIGUEZ, P.E. License Number 60236. PROJECT NO.: 2016-17. SHEET NO.: E-3. CHECKED BY: A.R. SCALE: AS SHOWN. 2016 BY: CDS.

engineering inc. 2655 Le Jeune Road, Suite 1109, Miami Beach, FL 33133. Phone: 305.444.8809. Fax: 305.444.8827. Website: www.dfr-e.com