



Note: Upstairs usable floor space same as lower level due to angled walls on all 4 perimeter exterior walls, on upper level, walls not perpendicular to floor.

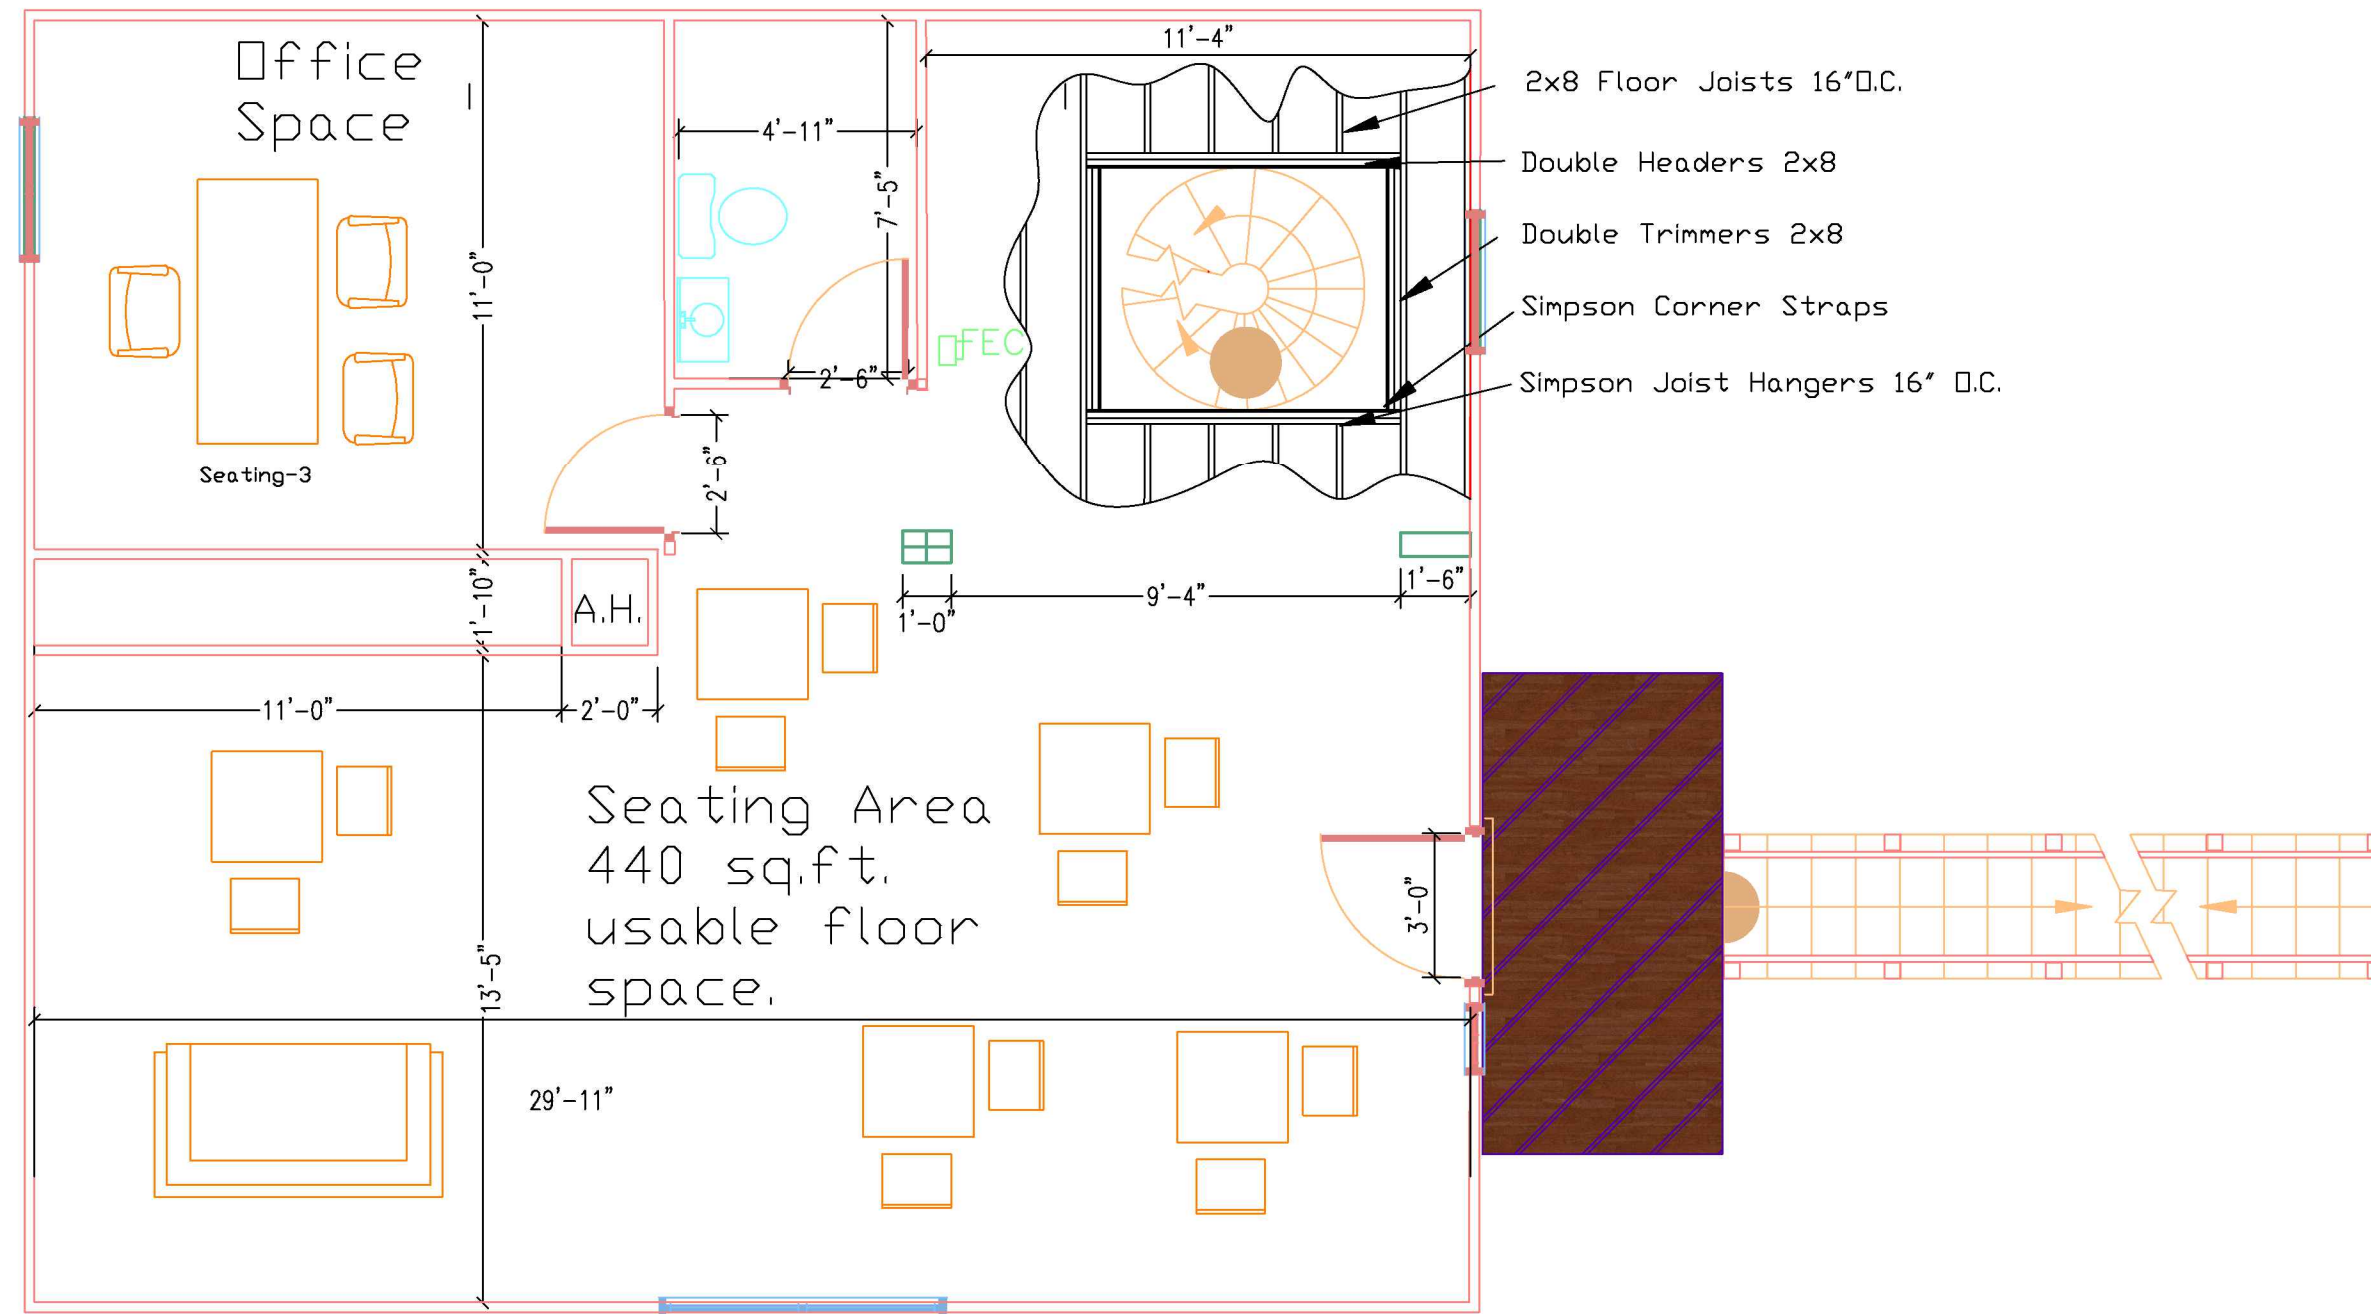

Upper Level

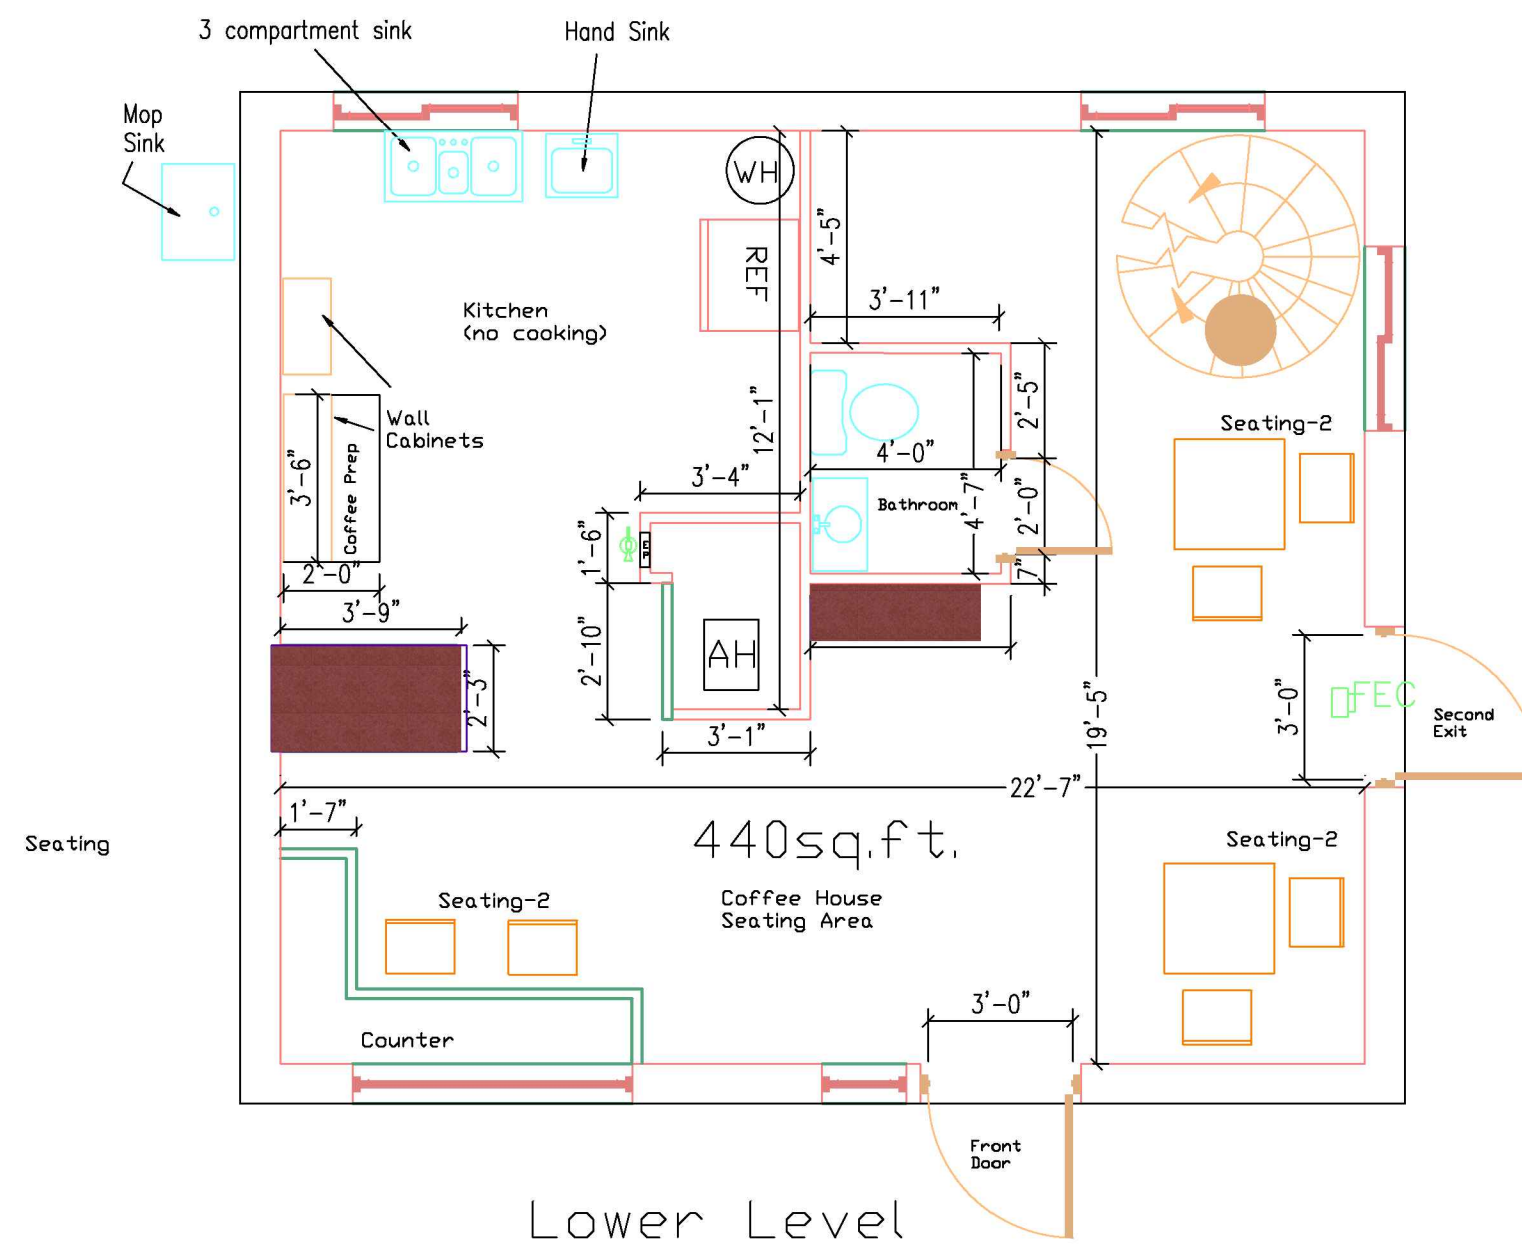

Lower Level

CONSULTANTS

OWNER
US IMPERIAL
 254 North Division St. Suite-A
 Oviedo, Florida 32765
 Division Street

Notes:
 No Sprinkler system

Electrical Legend

Symbol	Quantity
Switch	6
Outlet	5
Quad Outlet	4
Incandescent Light	5
Exterior Light	3
Exhaust Fan	1
Electrical Pannel	1

MARK	DATE	DESCRIPTION

PROJECT NO: _____
 CAD DWG FILE: 254 IMPERIAL.dwg
 DRAWN BY: Joe
 CHECKED BY: Joe
 COPYRIGHT: _____

SHEET TITLE Floor Plan
SHEET TITLE
 Coffee House

SHEET NUMBER
 SHEET NO. OF TOTAL SHEETS

Scale 1/4"=1'