

OLR

ARCHITECT

ORESTES LOPEZ-RECIO
AR0009350

5895 SW 32 ST
MIAMI, FLORIDA
33155
PHONE: (305)360-2836

OWNER:
1820 SW 3 AVE LLC
90 SW 3ST UNIT 7 (IVY LOBBY)
MIAMI FL 33130

PROPOSED INTERIOR
LEGALIZATION FOR:
1820 SW 3 AVE LLC
1820 SW 3RD AVE
MIAMI FLORIDA, 33129

SEAL

REVISIONS
B.D.C. 10.12.24

DATE 07-31-24

SCALE AS SHOWN

DRAWN : OLR


JOB NO. : 24-2670

A-08

SHEET NO.: OF

LEGEND:

- NO CEILING INDICATES EXPOSED UNDERSIDE OF STRUCTURE
- CEILING MOUNTED LIGHT FIXTURE.
- HI-HATS AT PUBLIC AREAS
- 24"x24" LED. SEE ELECTRICAL PLANS.
- FLUORESCENT LAMP
- SUSPENDED ACOUSTICAL CEILING TILE 24"x24".
- SUSPENDED GYP. BOARD CEILING

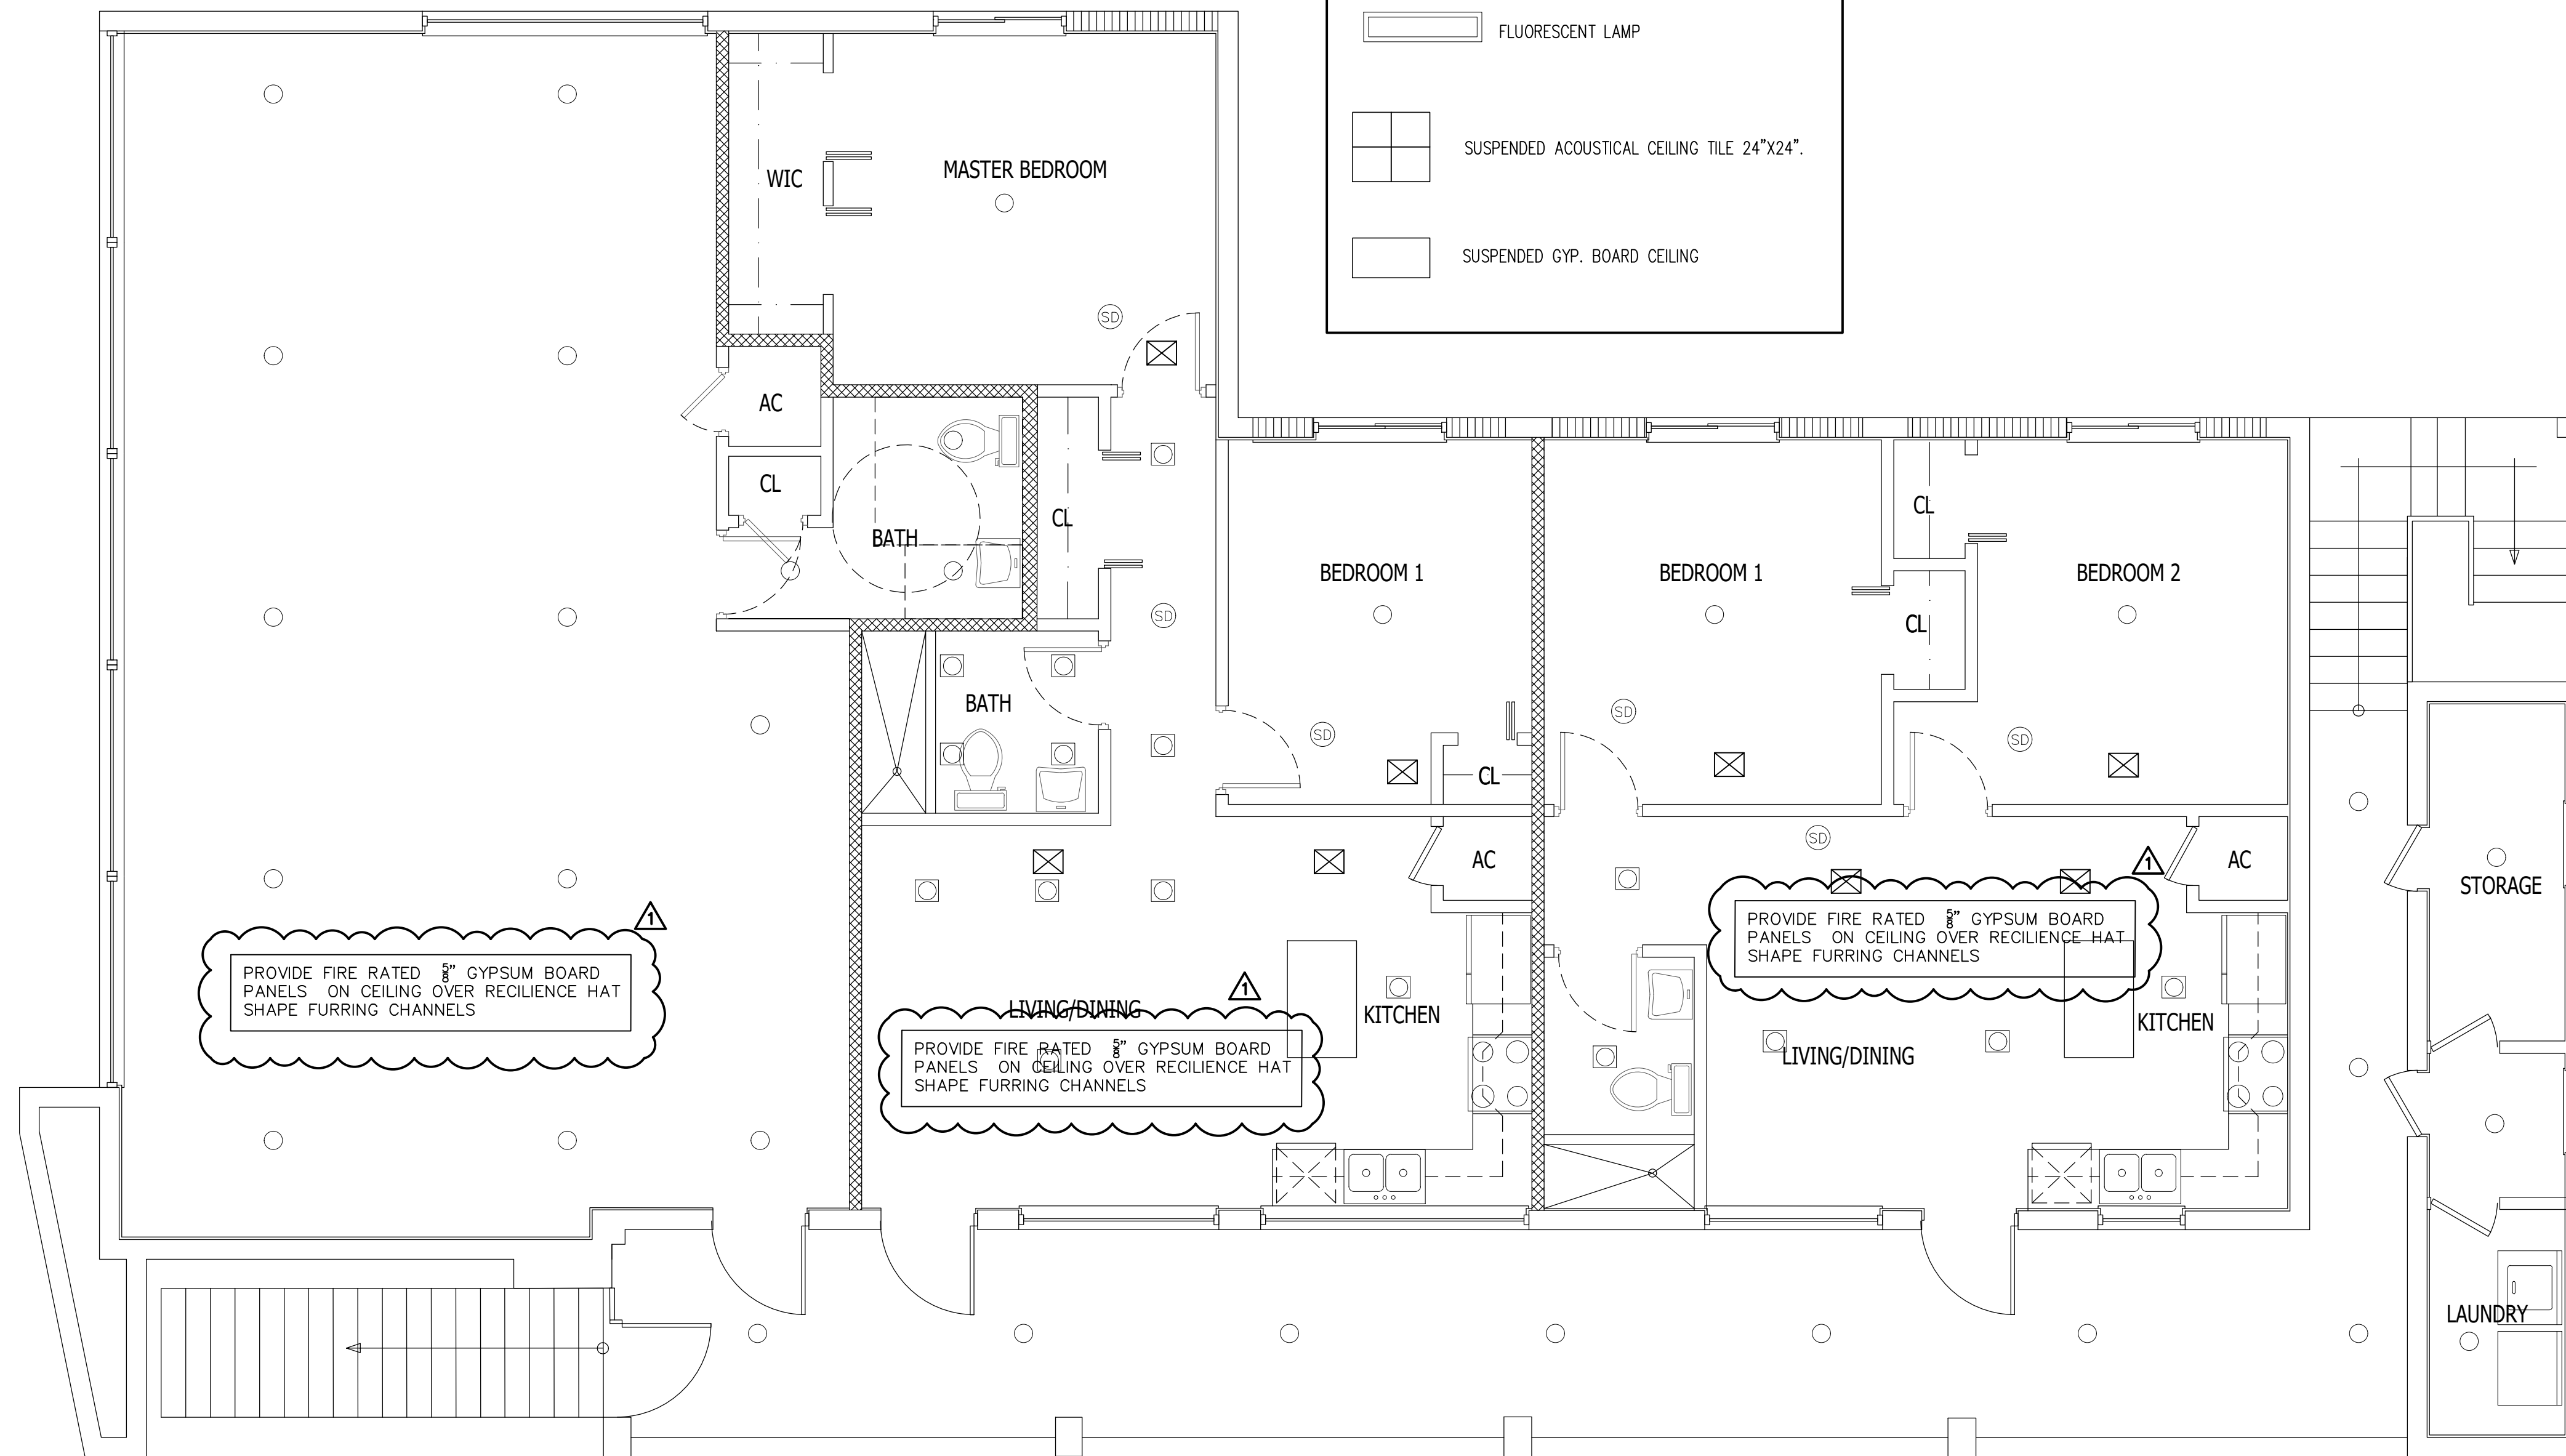

PROPOSED RCP SECOND FLOOR

SCALE: 1/4" = 1'-0"

